



LUMINAIRE SCHEDULE							
Symbol	Label	Qty	Catalog Number	Description	Lamp	File	Lumens LfH Watts
○	4	20	TV 1500M GPHD+ UV	SPUN PARABOLIC FLOODLIGHT - NEMA 4 DISTRIBUTION	MH 1500RU/MOR	TV_4_1M.BF.6	155000 0.90 1610

STATISTICS						
Description	Symbol	Avg	Max	Min	Max/Min	Avg/Min
CALCS	+	0.9 fc	16.2 fc	0.0 fc	N/A	N/A

NOTES
1. POLE HEIGHT 40.0 FEET

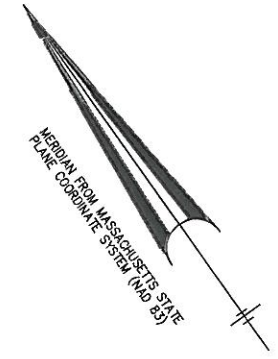

LOT 1
(PLAN NO 568 OF 1999)
183.18± Acres

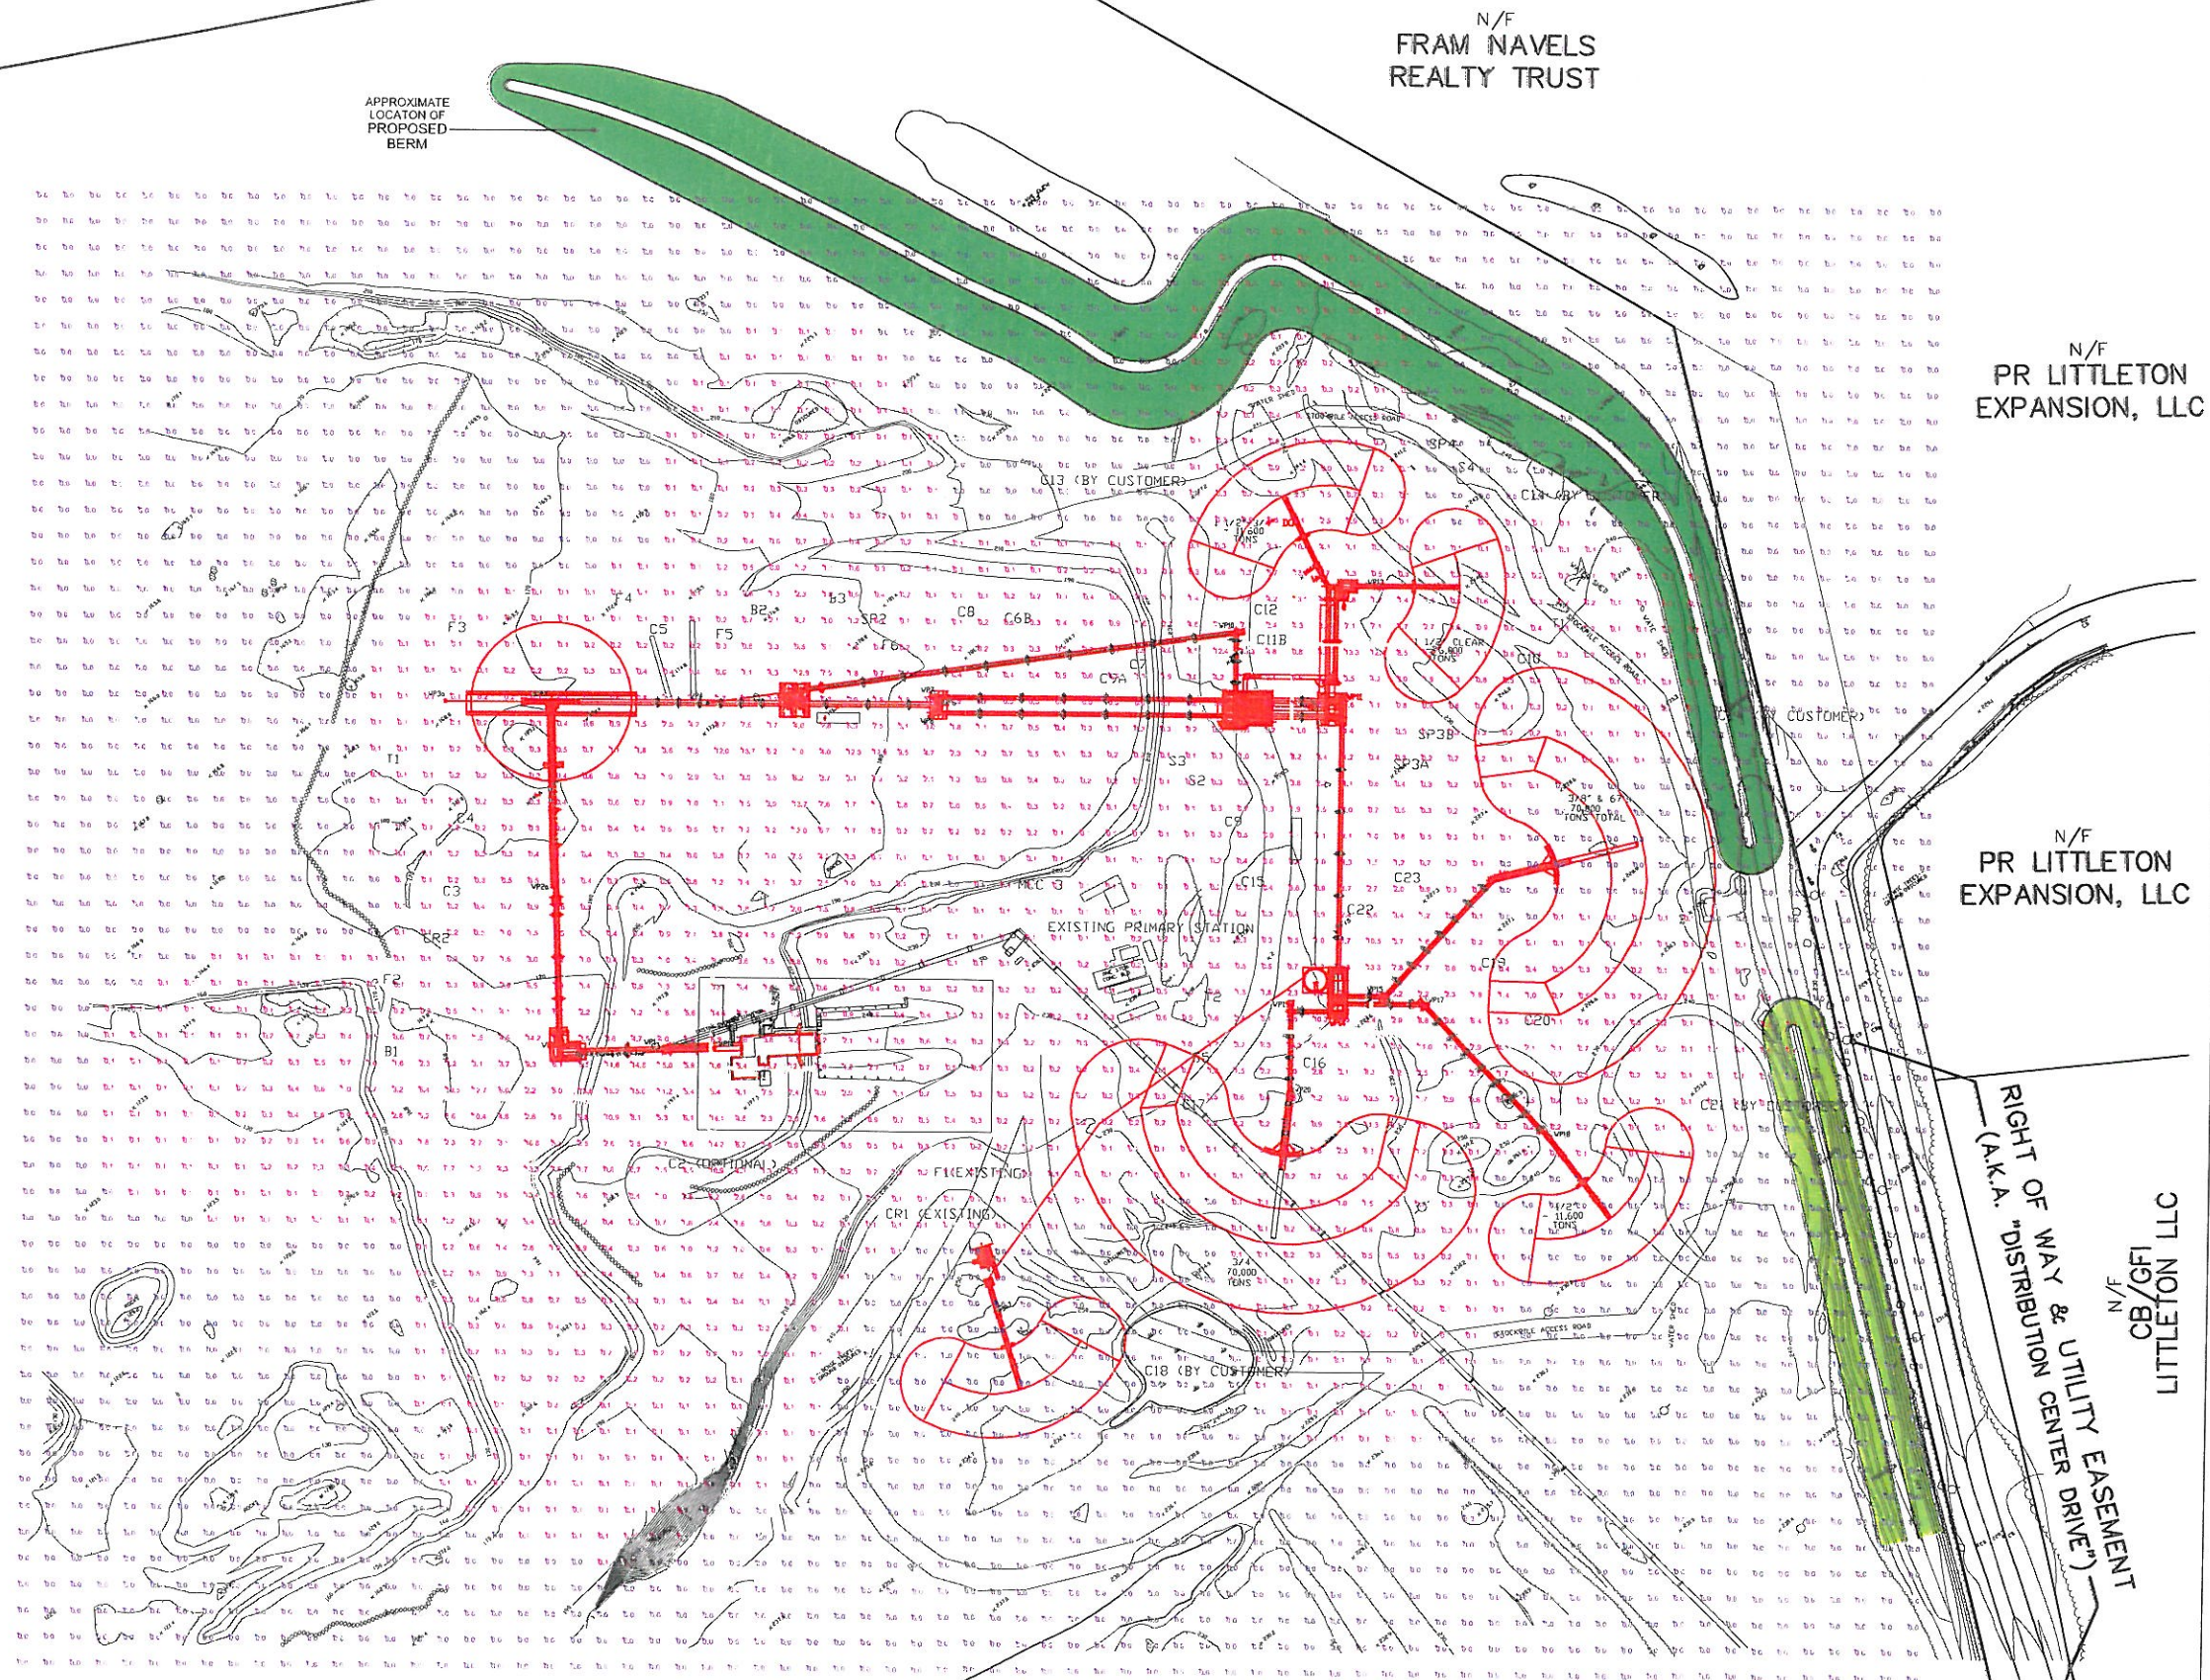

N/F
FRAM NAVELS
REALTY TRUST

N/F
PR LITTLETON
EXPANSION, LLC

N/F
PR LITTLETON
EXPANSION, LLC

N/F
CB/GFI
LITTLETON LLC

RIGHT OF WAY & UTILITY EASEMENT
(A.K.A. "DISTRIBUTION CENTER DRIVE")

AGGREGATE INDUSTRIES

SITE LIGHTING
POINT ILLUMINATION STUDY

*Rec'd
2/25/10*

Designer	R.A. MCILRATH
Date	Feb 23 2010
Scale	AS NOTED
Drawing No.	261-00610A1